





Technical drawing of a rectangular room layout. The drawing includes dimensions: a vertical dimension of (25.5) on the left and a horizontal dimension of 18X (3) on the bottom right. The room contains various furniture items represented by symbols: circular tables, square tables, rectangular tables, and chairs. There are also some symbols that look like small squares or rectangles, possibly representing storage units or other furniture. The layout is symmetrical, with furniture arranged along the walls and in the center of the room.

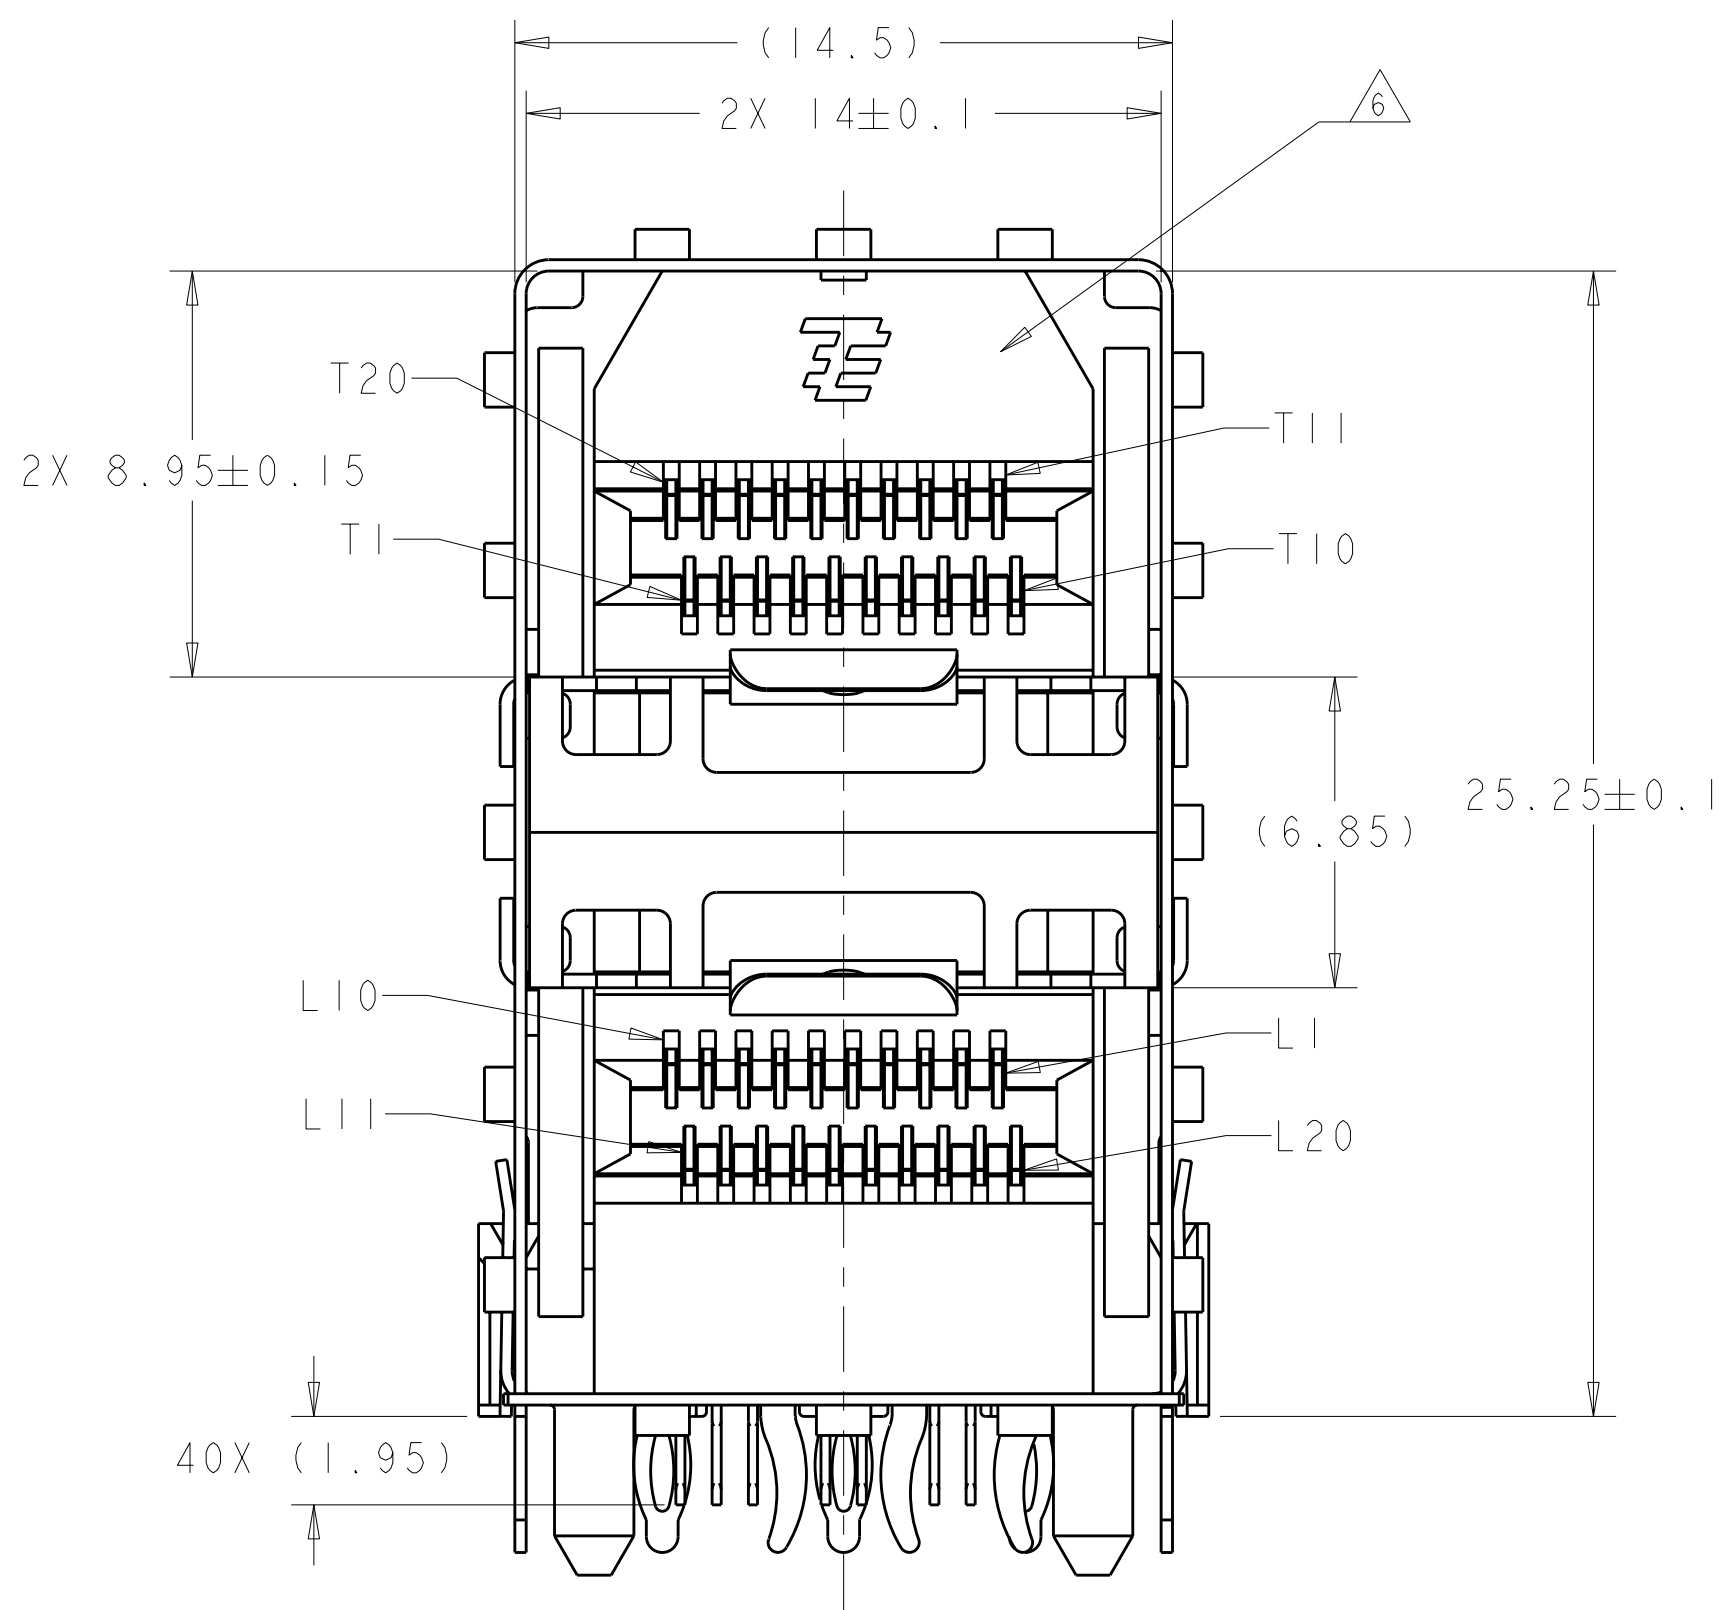

-
- Technical floor plan of a classroom. The room is rectangular with a dashed line down the center. On the left side, there are two rows of desks and chairs, labeled 4 and 8. A door is located at the bottom left. On the right side, there are two rows of desks and chairs, and a door is located at the top right. The overall dimensions are indicated as 63.25 units wide and 10.00 units deep.




THIS DRAWING IS THE PROPERTY OF TYCO ELECTRONICS LTD. IT IS TO BE USED FOR THE SPECIFIC APPLICATION AND CANNOT BE REPRODUCED OR COPIED IN ANY MANNER WITHOUT THE WRITTEN PERMISSION OF TYCO ELECTRONICS LTD. IT IS TO BE DESTROYED WHEN NO LONGER REQUIRED. IT IS TO BE KEPT UNDER LOCK AND KEY AND NOT TO BE LOANED TO ANY OTHER PERSON. IT IS TO BE RETURNED TO TYCO ELECTRONICS LTD. WHEN NO LONGER REQUIRED. IT IS TO BE KEPT UNDER LOCK AND KEY AND NOT TO BE LOANED TO ANY OTHER PERSON. IT IS TO BE RETURNED TO TYCO ELECTRONICS LTD. WHEN NO LONGER REQUIRED.		OWN 25MAR03 COWHER 23JAN04 KOPPENHEFFER 23JAN04 WILMSLEY 23JAN04		 Tyco Electronics Shanghai, China	
DIMENSIONS:		TOLERANCES, UNLESS OTHERWISE SPECIFIED:		NAME	
mm		0 PLC ± 1 PLC ± 2 PLC ±0.1 3 PLC ± 4 PLC ± 5 PLC ± ANGLES ±		CAGE AND PT CONNECTOR ASSEMBLY, 2x1, PRESS FIT, STANDARD PROFILE, SFP	
		PRODUCT SPEC 108-2161 APPLICATION SPEC 114-13103		SIZE CAGE CODE DRAWING NO A 00779 C=1658391	
MATERIAL -		FINISH -		RESTRICTED TO	
		CUSTOMER DRAWING		SCALE 2:1 SHEET 1 OF 3 REV F	

LOC		DIST		REVISIONS				
ES	00	P	LYR	DESCRIPTION	DATE	DWN	APVD	
		-	-	SEE SHEET 1	-	-	-	

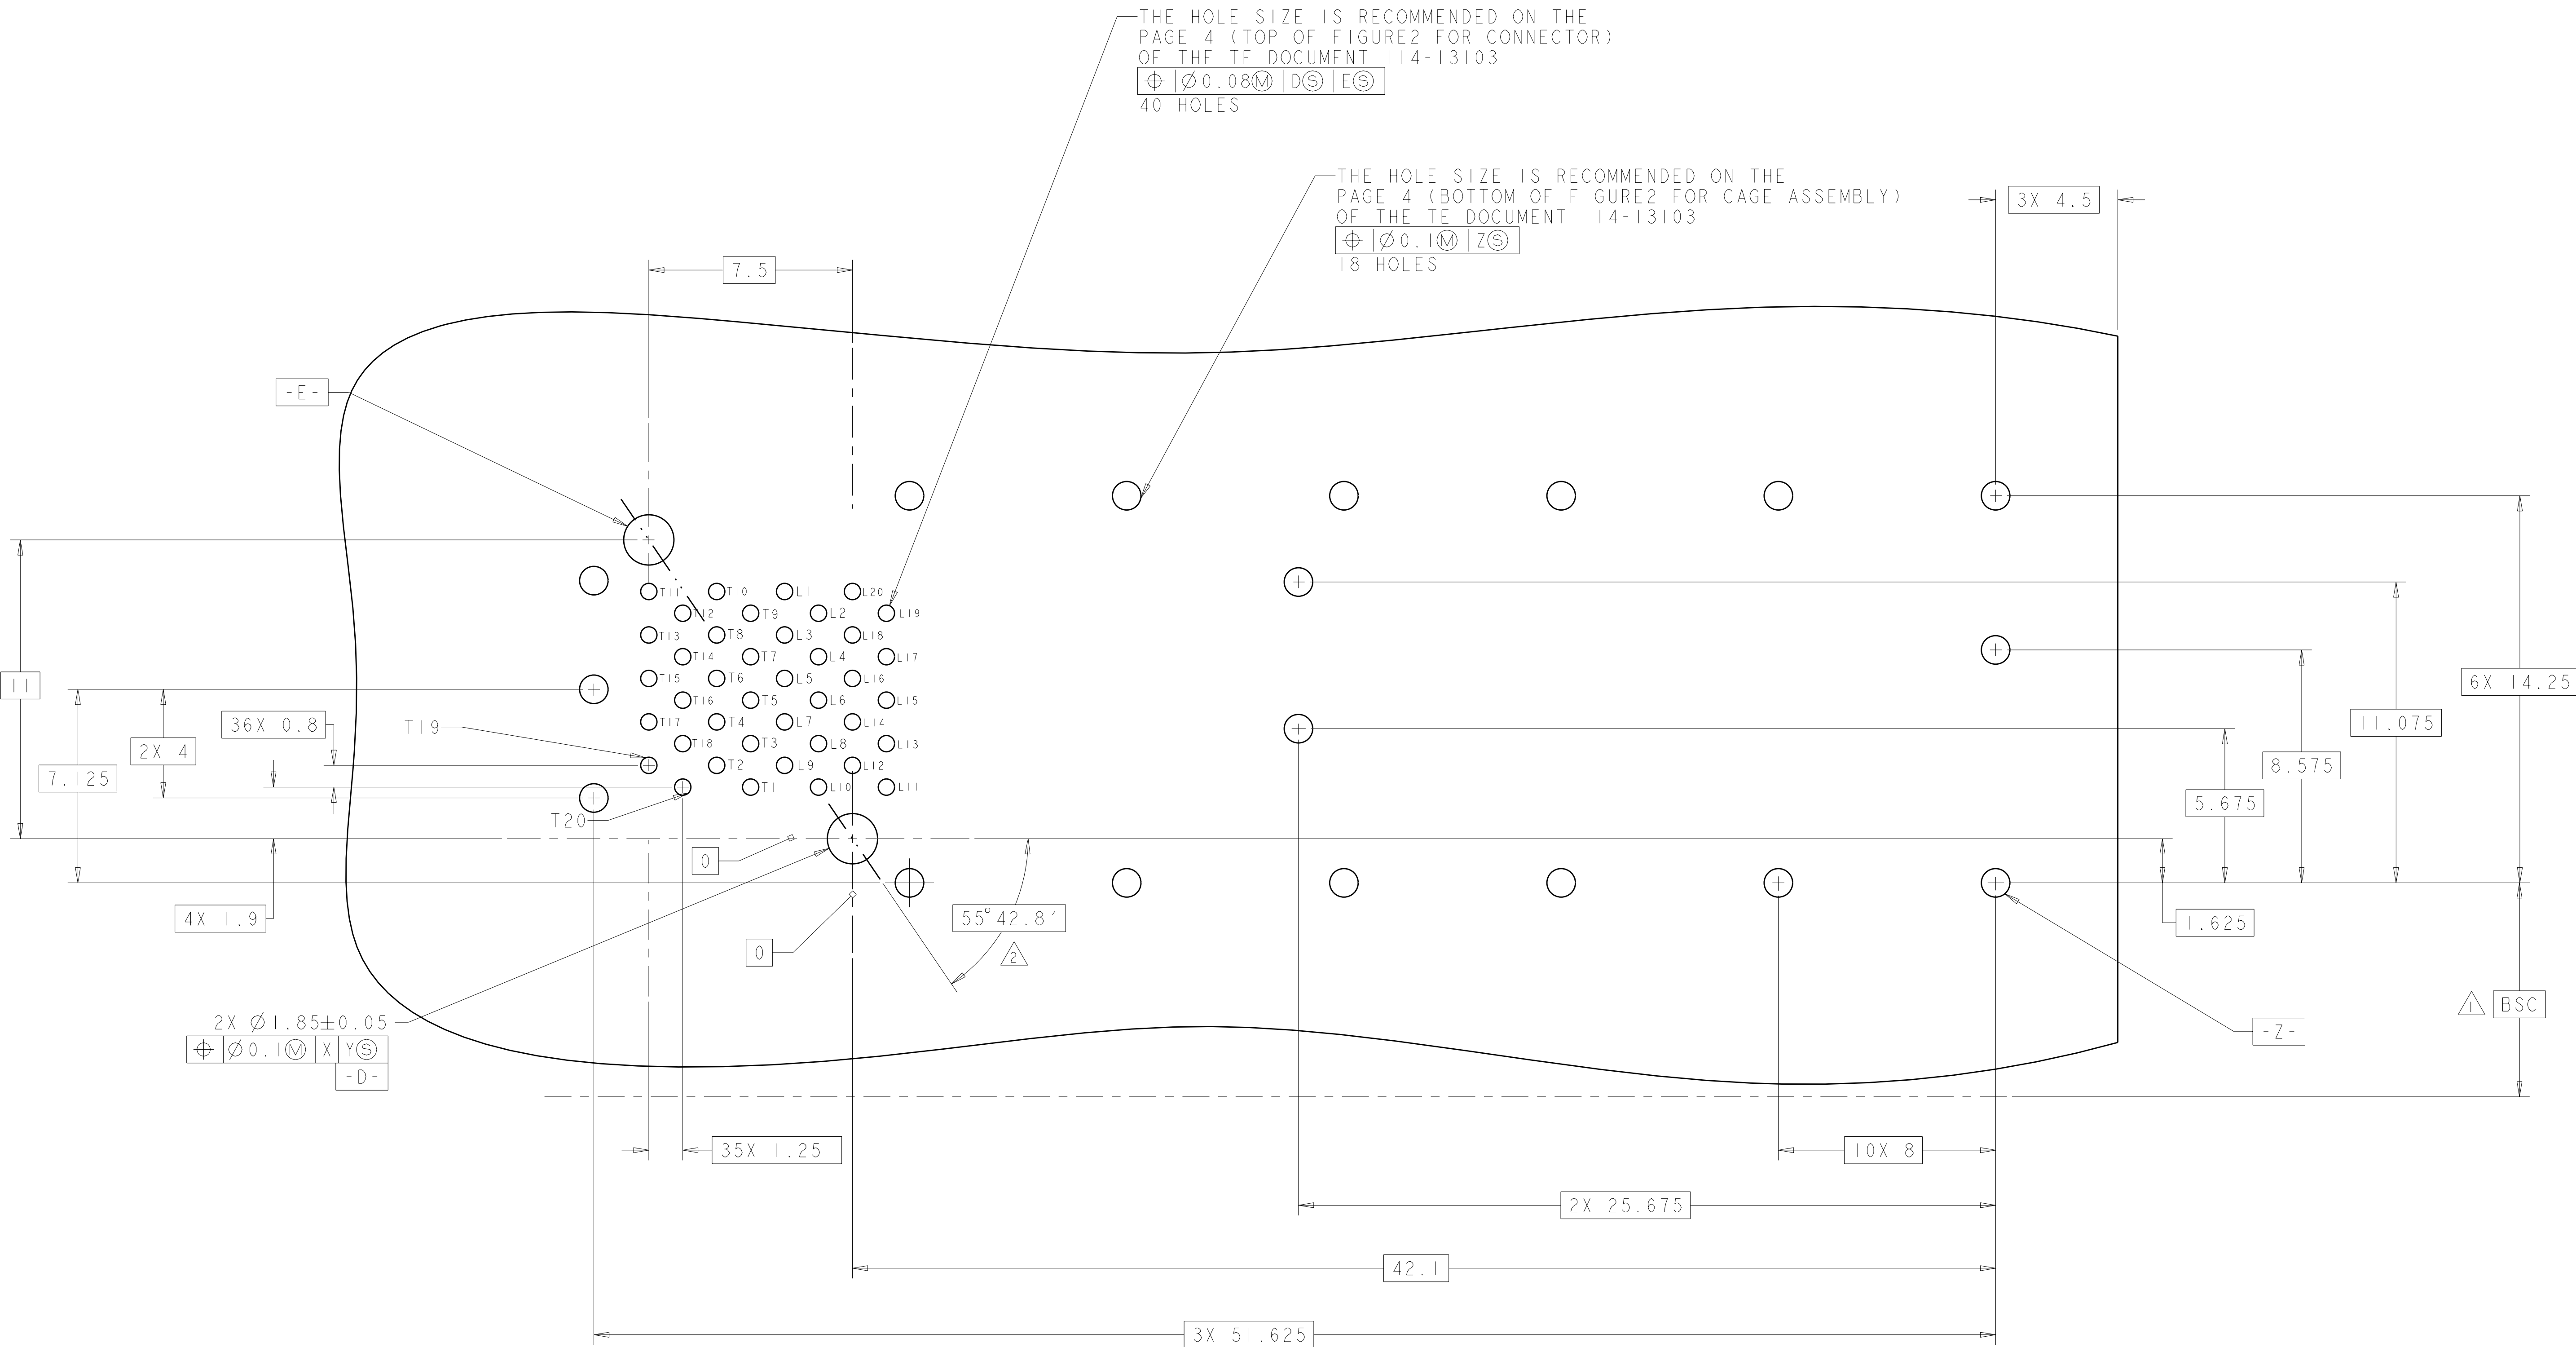

TYPICAL DIMENSIONS TO BE USED FOR THIS DRAWING. DIMENSIONS IN PARENTHESES ARE FOR INFORMATION ONLY. DIMENSIONS IN PARENTHESES ARE FOR INFORMATION ONLY. DIMENSIONS IN PARENTHESES ARE FOR INFORMATION ONLY.		DWN M. COWHER	25MAR03	Tyco Electronics Shanghai, China	
CHK J. KOPPENHEFFER		23JAN04	23JAN04	NAME CAGE AND PT CONNECTOR ASSEMBLY, 2x1, PRESS FIT, STANDARD PROFILE, SFP	
APVD M. WALMSLEY		23JAN04	23JAN04	SIZE A1	
PRODUCT SPEC 108-2161		APPLICATION SPEC 114-13103		CAGE CODE 00779	
MATERIAL -		WEIGHT -		DRAWING NO. C=1658391	
FINISH -		CUSTOMER DRAWING		RESTRICTED TO -	
DIMENSIONS: mm		TOLERANCES UNLESS OTHERWISE SPECIFIED:		SCALE 2:1	
9 PLC ±0.1		±0.1		SHEET 2 OF 3	
3 PLC ±0.1		±0.1		REV F	
4 PLC ±0.1		±0.1			
ANGLES ±0.1		±0.1			

LOC	DIST	REVISIONS					
ES	00	P	LTR	DESCRIPTION	DATE	DWN	APVD
			-	SEE SHEET 1	-	-	-

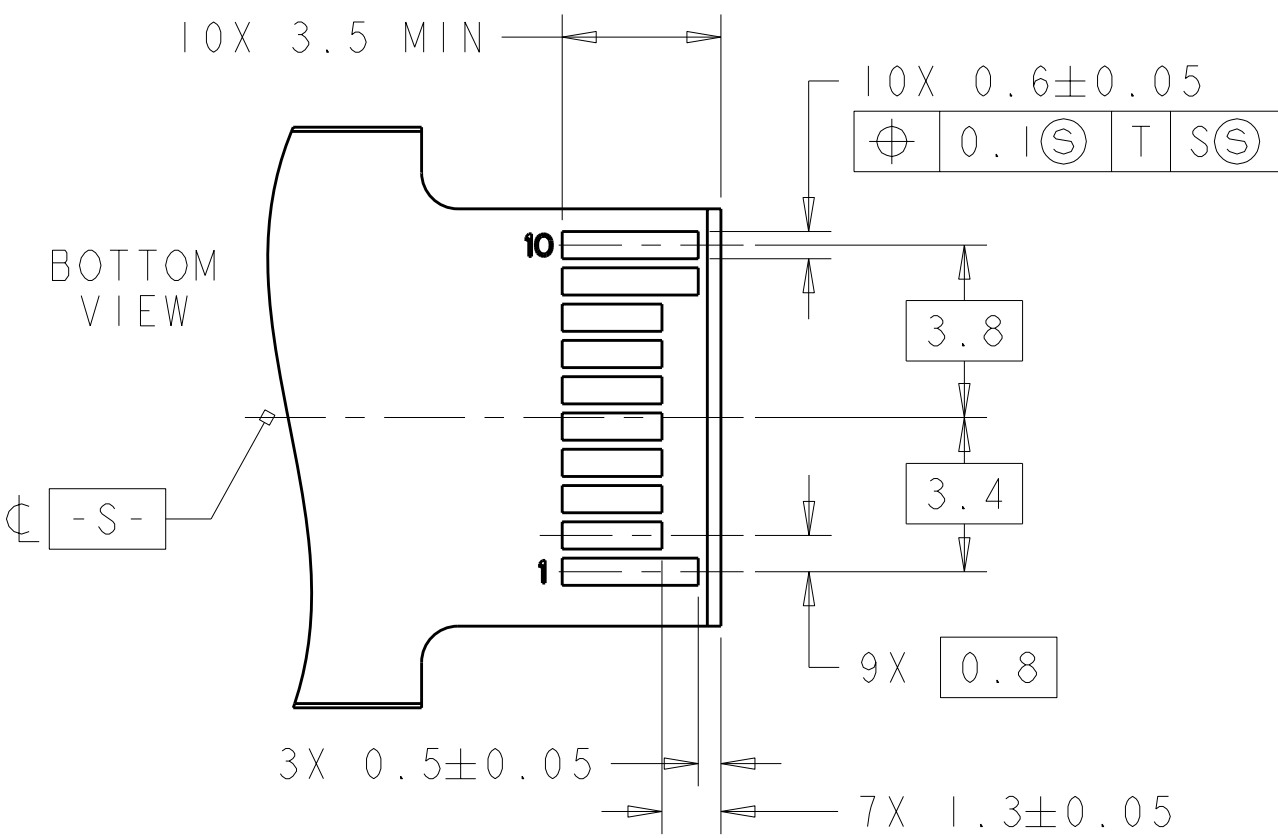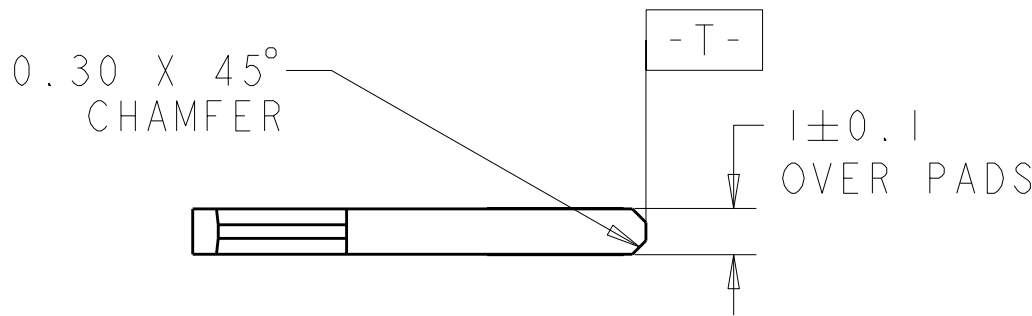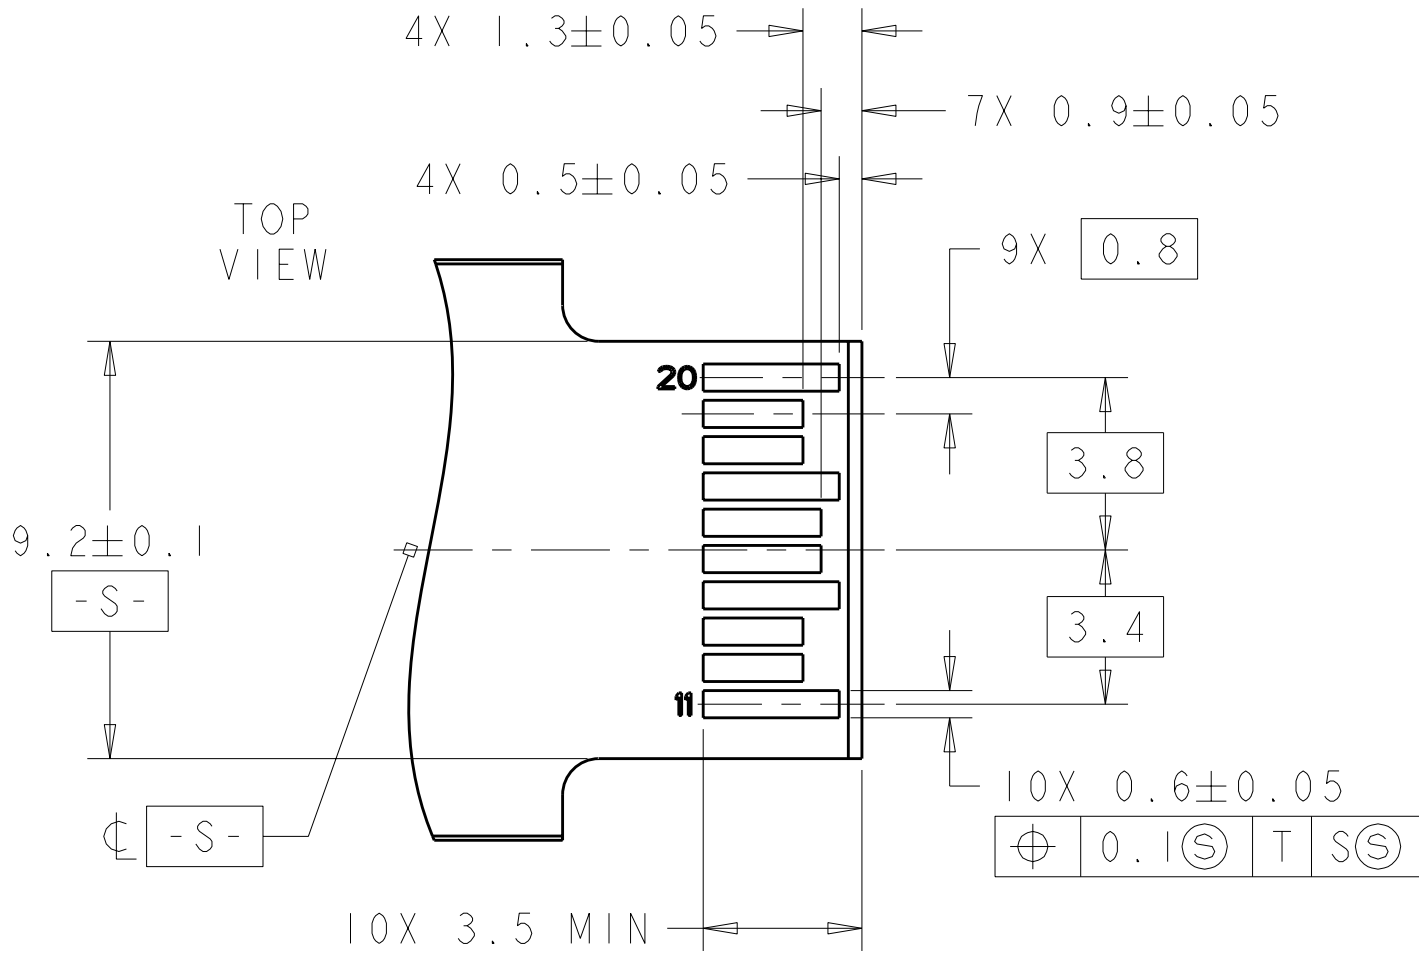

RECOMMENDED LAYOUT FOR
MATING TRANSCEIVER PCB
SCALE 6:1

NOTE: DRAWING 114-13103 IS CONTROLLED TOGETHER WITH THE ELECTRONS CORPORATION 114-13103-01. ANY INFORMATION OR CHANGES TO THIS DRAWING MUST BE OBTAINED BY CONTACTING THE TSCU LATEST RELEASE.				DWN M. COWHER 25MAR03		 Tyco Electronics Shanghai, China					
DIMENSIONS: mm				TOLERANCES UNLESS OTHERWISE SPECIFIED:				CHK J. KOPPENHEFFER 23JAN04		NAME CAGE AND PT CONNECTOR ASSEMBLY, 2x1, PRESS FIT, STANDARD PROFILE, SFP	
								APVD M. WALMSLEY 23JAN04			
				9 PLC ± 1 PLC ± 2 PLC ±0.1 3 PLC ± 4 PLC ± ANGLES ± FINISH ±				PRODUCT SPEC 108-2161		SIZE CAGE CODE DRAWING NO A 00779 C=1658391	
								APPLICATION SPEC 114-13103			
MATERIAL -				WEIGHT -				CUSTOMER DRAWING		RESTRICTED TO -	
								SCALE 1:1		SHEET 3 OF 3	
								REV F			